


BUILDING COMPLEX

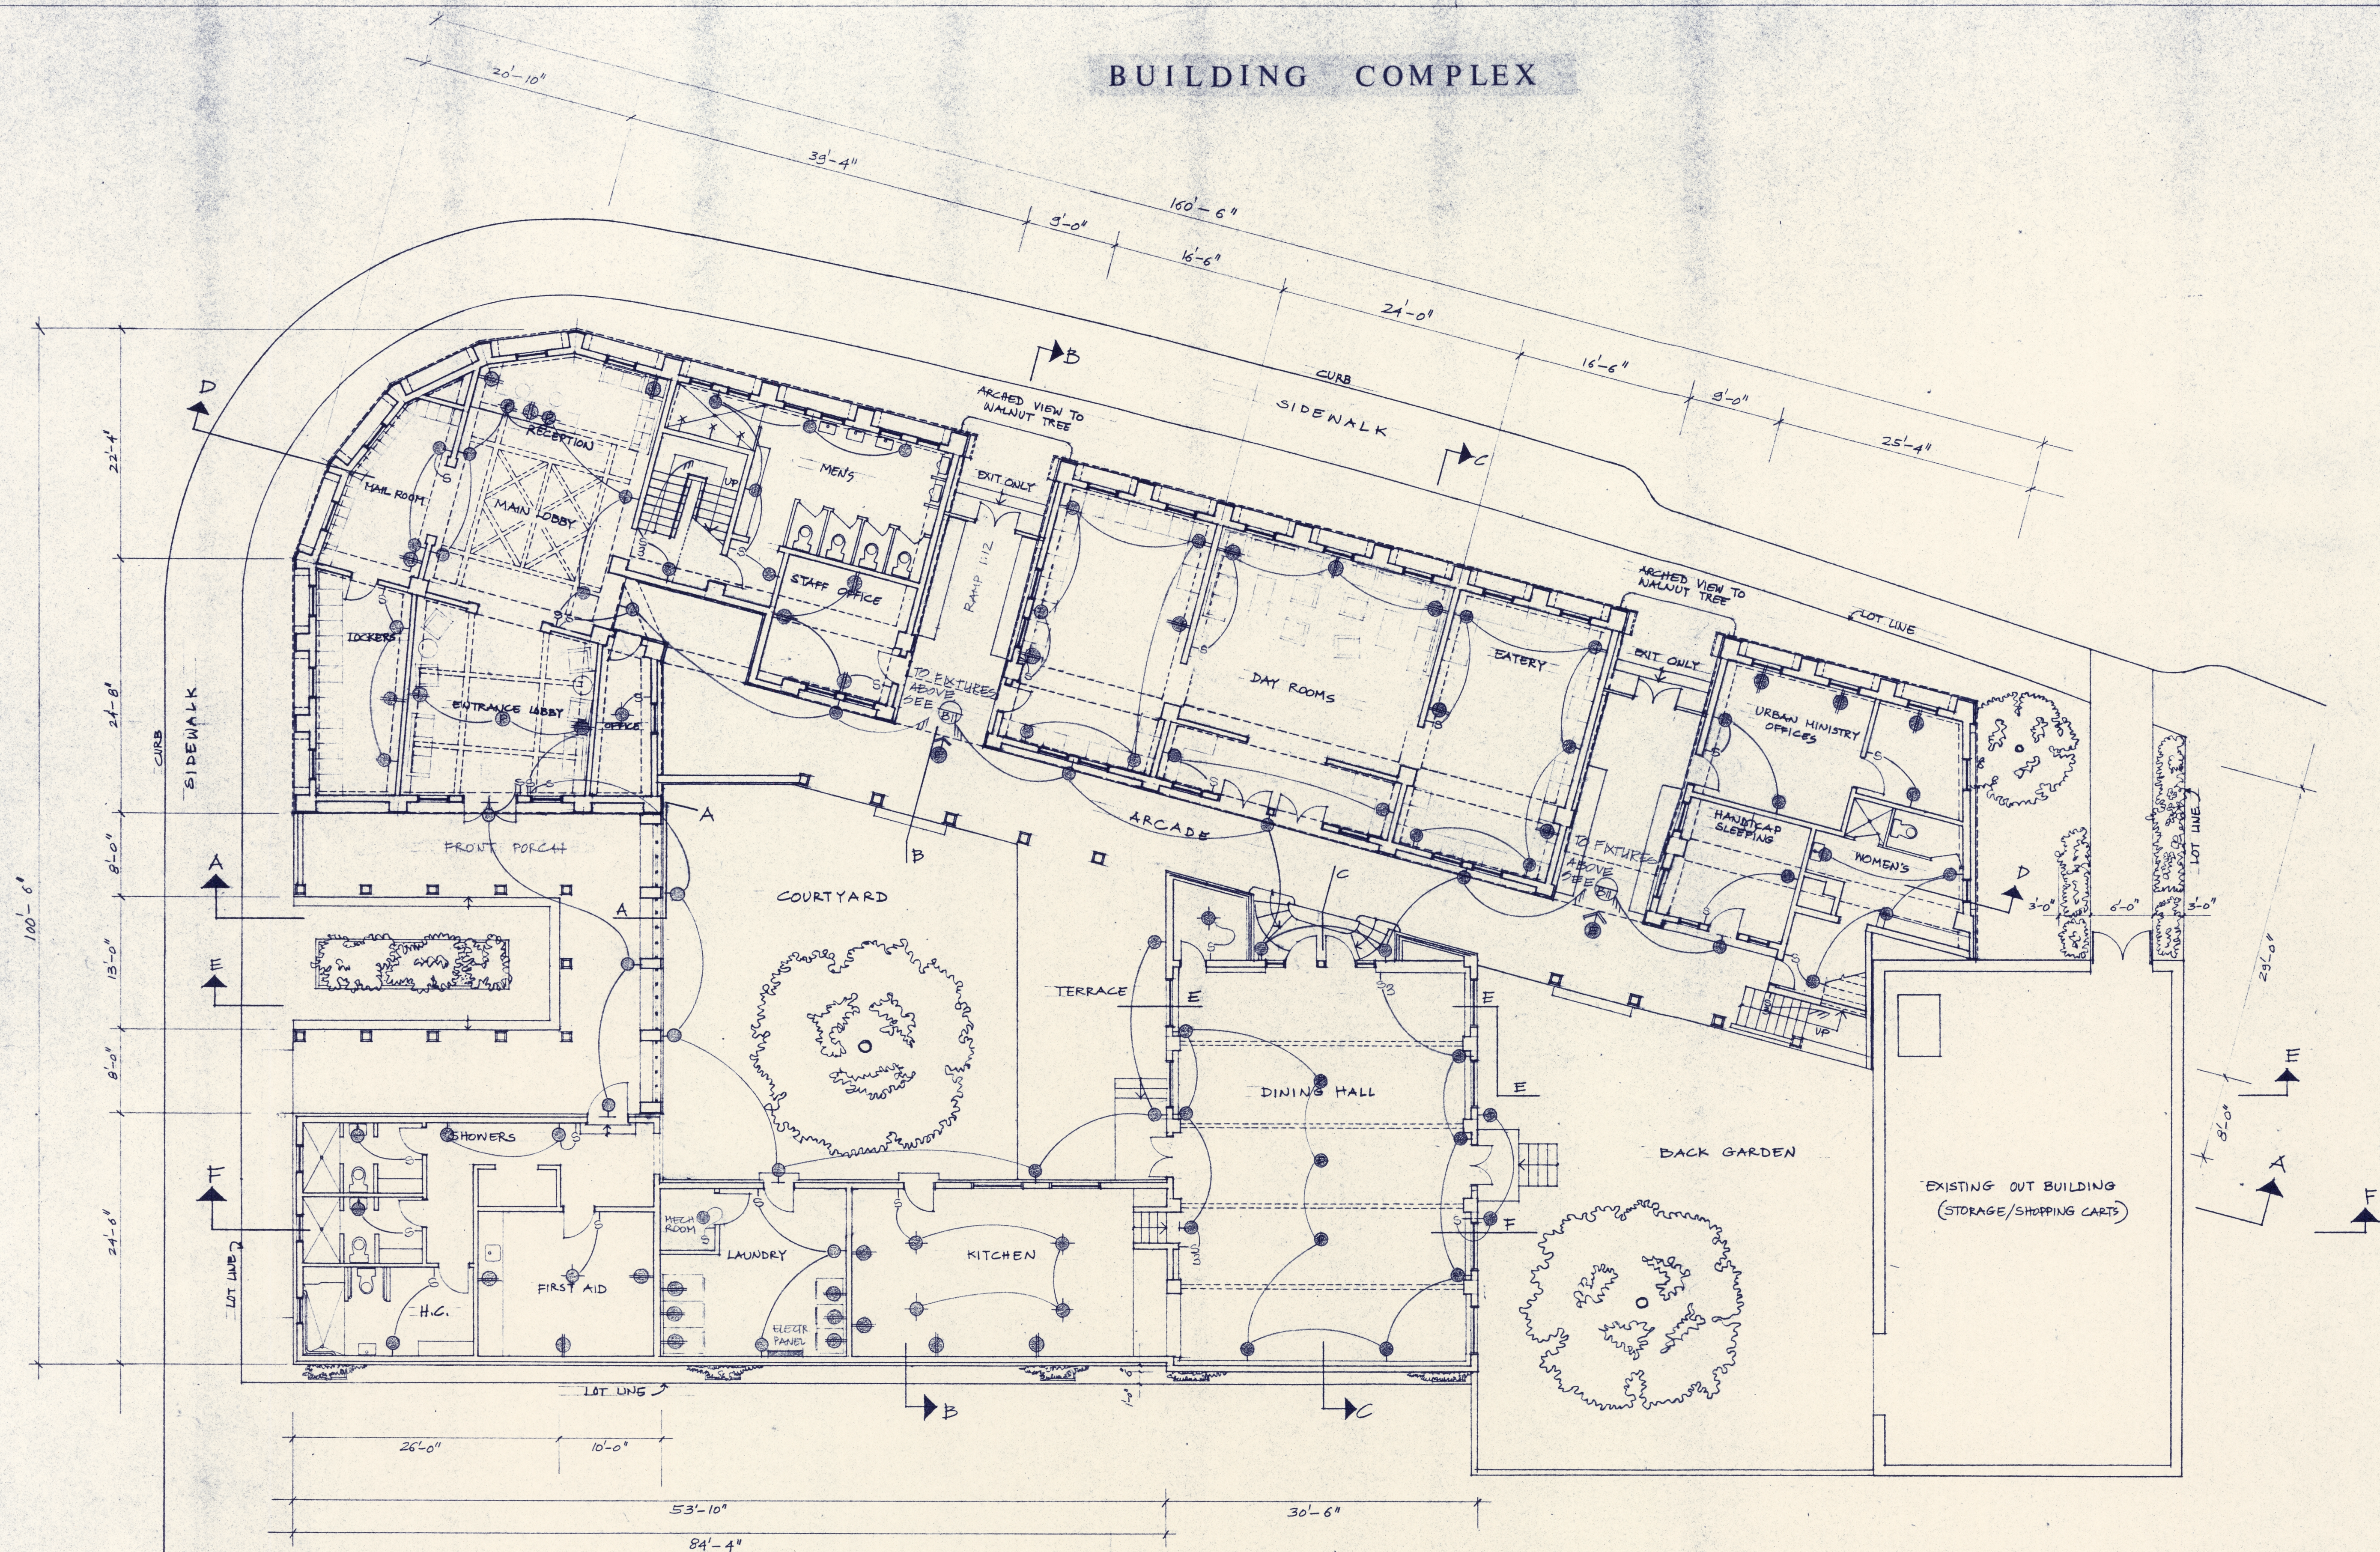

LEGEND

- CEILING FIXTURE
- PENDANT CEILING FIXTURE
- ➔ ILLUMINATED EMERGENCY EXIT SIGN (WITH DIRECTIONAL ARROWS AS INDICATED)
- WALL MOUNTED FIXTURE
- DUPLEX WALL OUTLET
- DUPLEX WALL OUTLET W/ SPLIT SWITCHING
- S SWITCH
- S₃ 3-WAY SWITCH

NOTE: ALL SWITCHES MAX 4'-0", MIN 3'-0" HEIGHT
WALL OUTLETS: MIN 1'-0" ABOVE THE FLOOR EXCEPT AT WINDOW WALLS

ELECTRICAL PLAN - GROUND FLOOR
SCALE 1/8" = 1'-0"

DATE: JULY 10, 1987

